

Notes:
The contractor must verify all dimensions on site before commencing any work on shop drawings, do not scale from this drawing.
McBains Ltd copyright
BIM Transmittal Disclaimer



McBains Ltd makes no express or implied warranties with respect to the accuracy, completeness, reliability, or the suitability of the data for any particular purpose beyond those originally intended by McBains Ltd. Please refer to our standard terms and conditions for further details.

NOTES

- 1 THE DRAWING SHALL BE READ IN CONJUNCTION WITH THE MECHANICAL AND ELECTRICAL SPECIFICATION
- 2 ALL SERVICES SHALL BE COORDINATED WITH THE ARCHITECT'S LAYOUTS AND TERMINAL POSITIONS OF GRILLES, LIGHTING, RADATORS, ETC TO SUIT INTERNAL LAYOUTS
- 3 THE CONTRACTOR SHALL ENSURE THAT ALL MECHANICAL AND BUILDERS WORK COMPLY WITH ALL LOCAL AUTHORITY, STATUTORY AND BUILDING CONTROL REQUIREMENTS. THE CONTRACTOR SHALL PROVIDE DETAILED INSTALLATION DRAWINGS FOR APPROVAL BY THE CLIENT

LEGEND

BT	EXISTING BT
BT(Fibre)	EXISTING BT FIBRE
ELEC	EXISTING GTC ELECTRICITY
GAS	EXISTING GTC GAS
IC	EXISTING INSTALCOM
NB	EXISTING NETWORK RAIL
XXX	EXISTING SEWER (ABANDONED)
SW	EXISTING SEWER (FW)
SW	EXISTING SEWER (SW)
G(LP)	EXISTING SOG GAS (LP)
G(MP)	EXISTING SOG GAS (MP)
WATER	EXISTING SOUTHERN WATER
WATER	EXISTING REDUNDANT SOUTHERN WATER
EL_HV	EXISTING URBN ELECTRICITY (HV)
EL_LV	EXISTING URBN ELECTRICITY (LV)
VZ	EXISTING VERIZON
VM	EXISTING VIRGIN MEDIA
VF	EXISTING VODAFONE

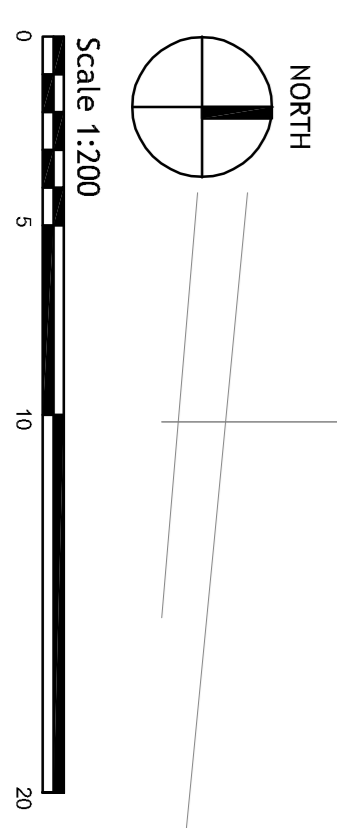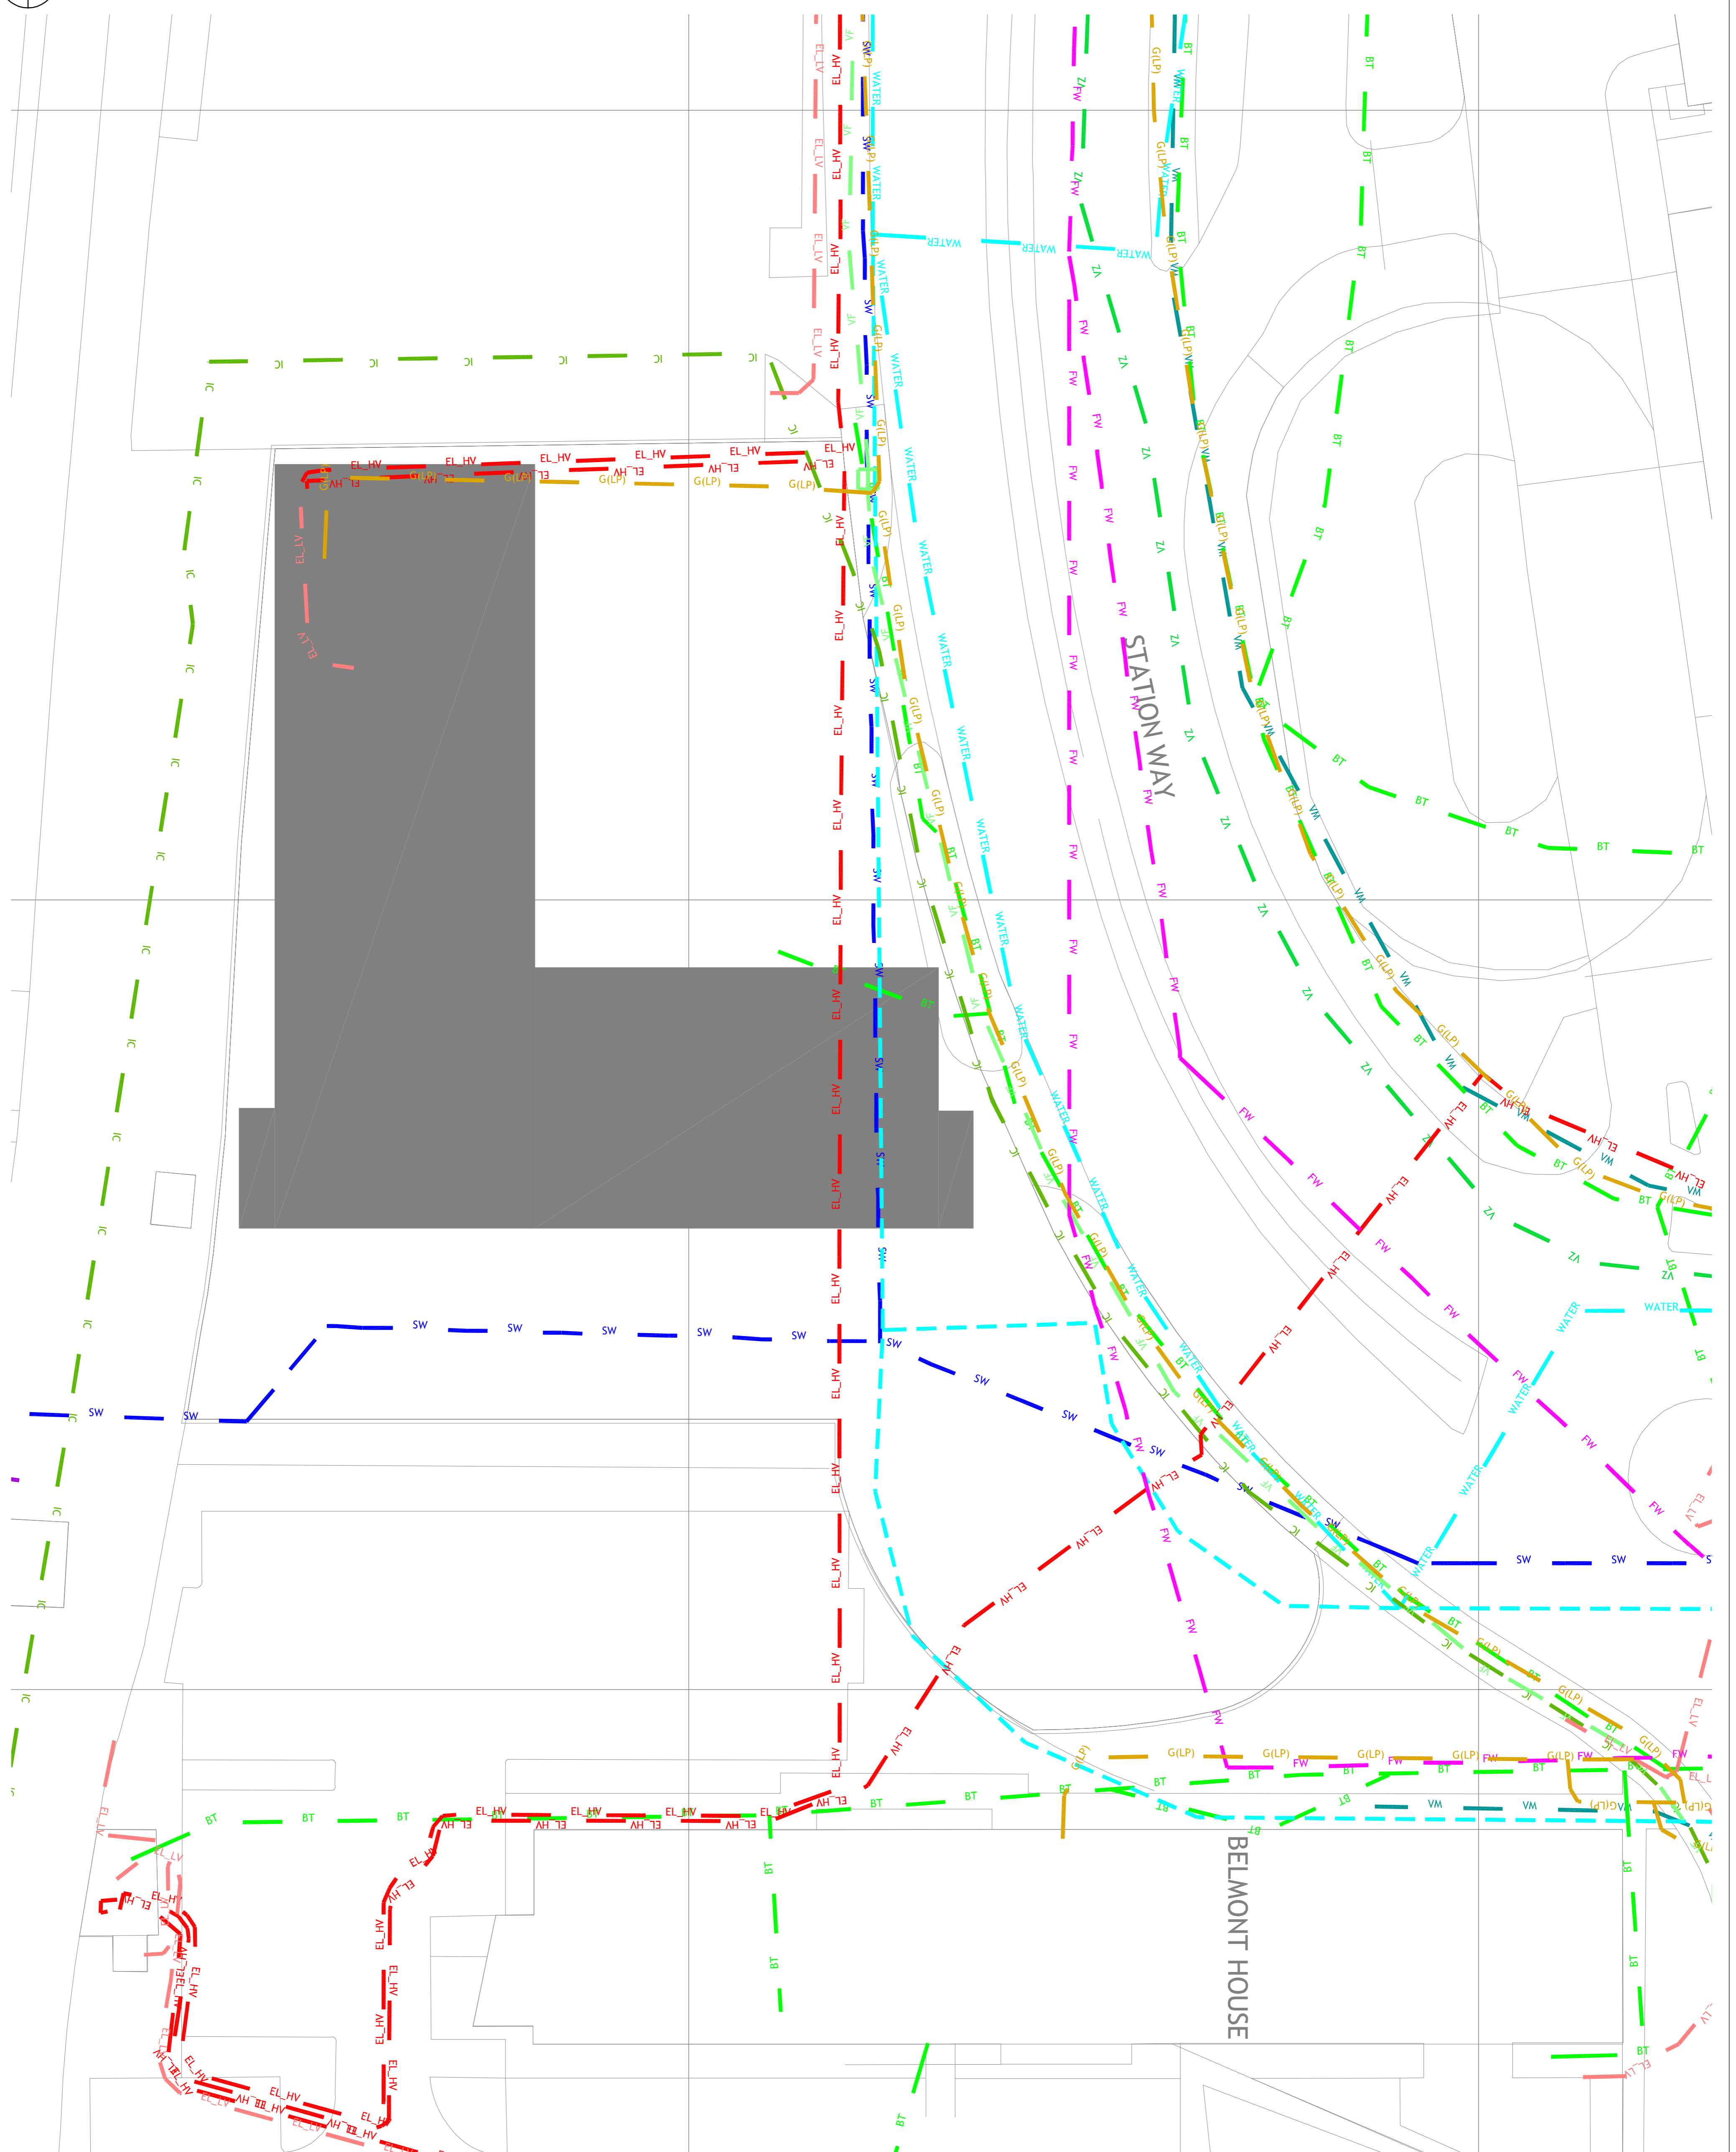

<p>McBains Ltd 5th Fl, 24 Finsbury Square, London EC2A 1BS +44 (0)20 7786 7900 mcbains.co.uk</p>	
<p>Client RAINIER DEVELOPMENTS LTD.</p>	
<p>Project MOKA, CRAWLEY</p>	
<p>Drawing Title SITE PLAN EXISTING UTILITY SERVICES OVERLAINED ONTO PROPOSED BUILDING LAYOUT</p>	
<p>MECH/ELEC/PH</p>	
<p>Revision</p>	<p>Amendment</p>
<p>P3 ISSUE FOR INFORMATION P2 ISSUE FOR INFORMATION P1 ISSUE FOR INFORMATION</p>	<p>03-05-19 22-02-19 16-01-19</p>
<p>M. Y.</p>	<p>L.B.</p>
<p>Drawn By</p>	<p>Agreed By</p>
<p>59833</p>	<p>1:200 @ A1</p>
<p>McB Number</p>	<p>Scale @ A1</p>
<p>Project Name</p>	<p>Zone</p>
<p>Level</p>	<p>Type</p>
<p>Discipline</p>	<p>Number</p>
<p>Standard</p>	<p>Revision</p>
<p>CMC01 - MCB - S1 - 00 - DR - E - 0200</p>	<p>S2 - P3</p>